

## SITE INSTRUCTION # 4

To: Barry Whitnell  
Construction Manager

Project: McRae Building  
553 Bonaccord Street,  
Peterborough, Ontario

Attn: Barry Whitnell

Project No: 16033

Date: November 8, 2018

*Please proceed with the following clarifications or changes to the Contract Documents. These clarifications or changes, proposed to modify the original contract documents, are not expected to affect the Contract Price or the Contract Schedule. All materials and workmanship are to be as described in the Contract Documents unless otherwise stated.*

### DESCRIPTION:


#### 1. Sanitary Sewer Arrangement West Wing:

See attached drawing for re-arrangement of sanitary sewer, now exiting the building at the south west corner of the building.

PREPARED BY THE CONSULTANT: Gregg Gordon Architect




Signed: \_\_\_\_\_ Title: Contract Administrator Date: November 8, 2018  
Gregg Gordon, O.A.A.

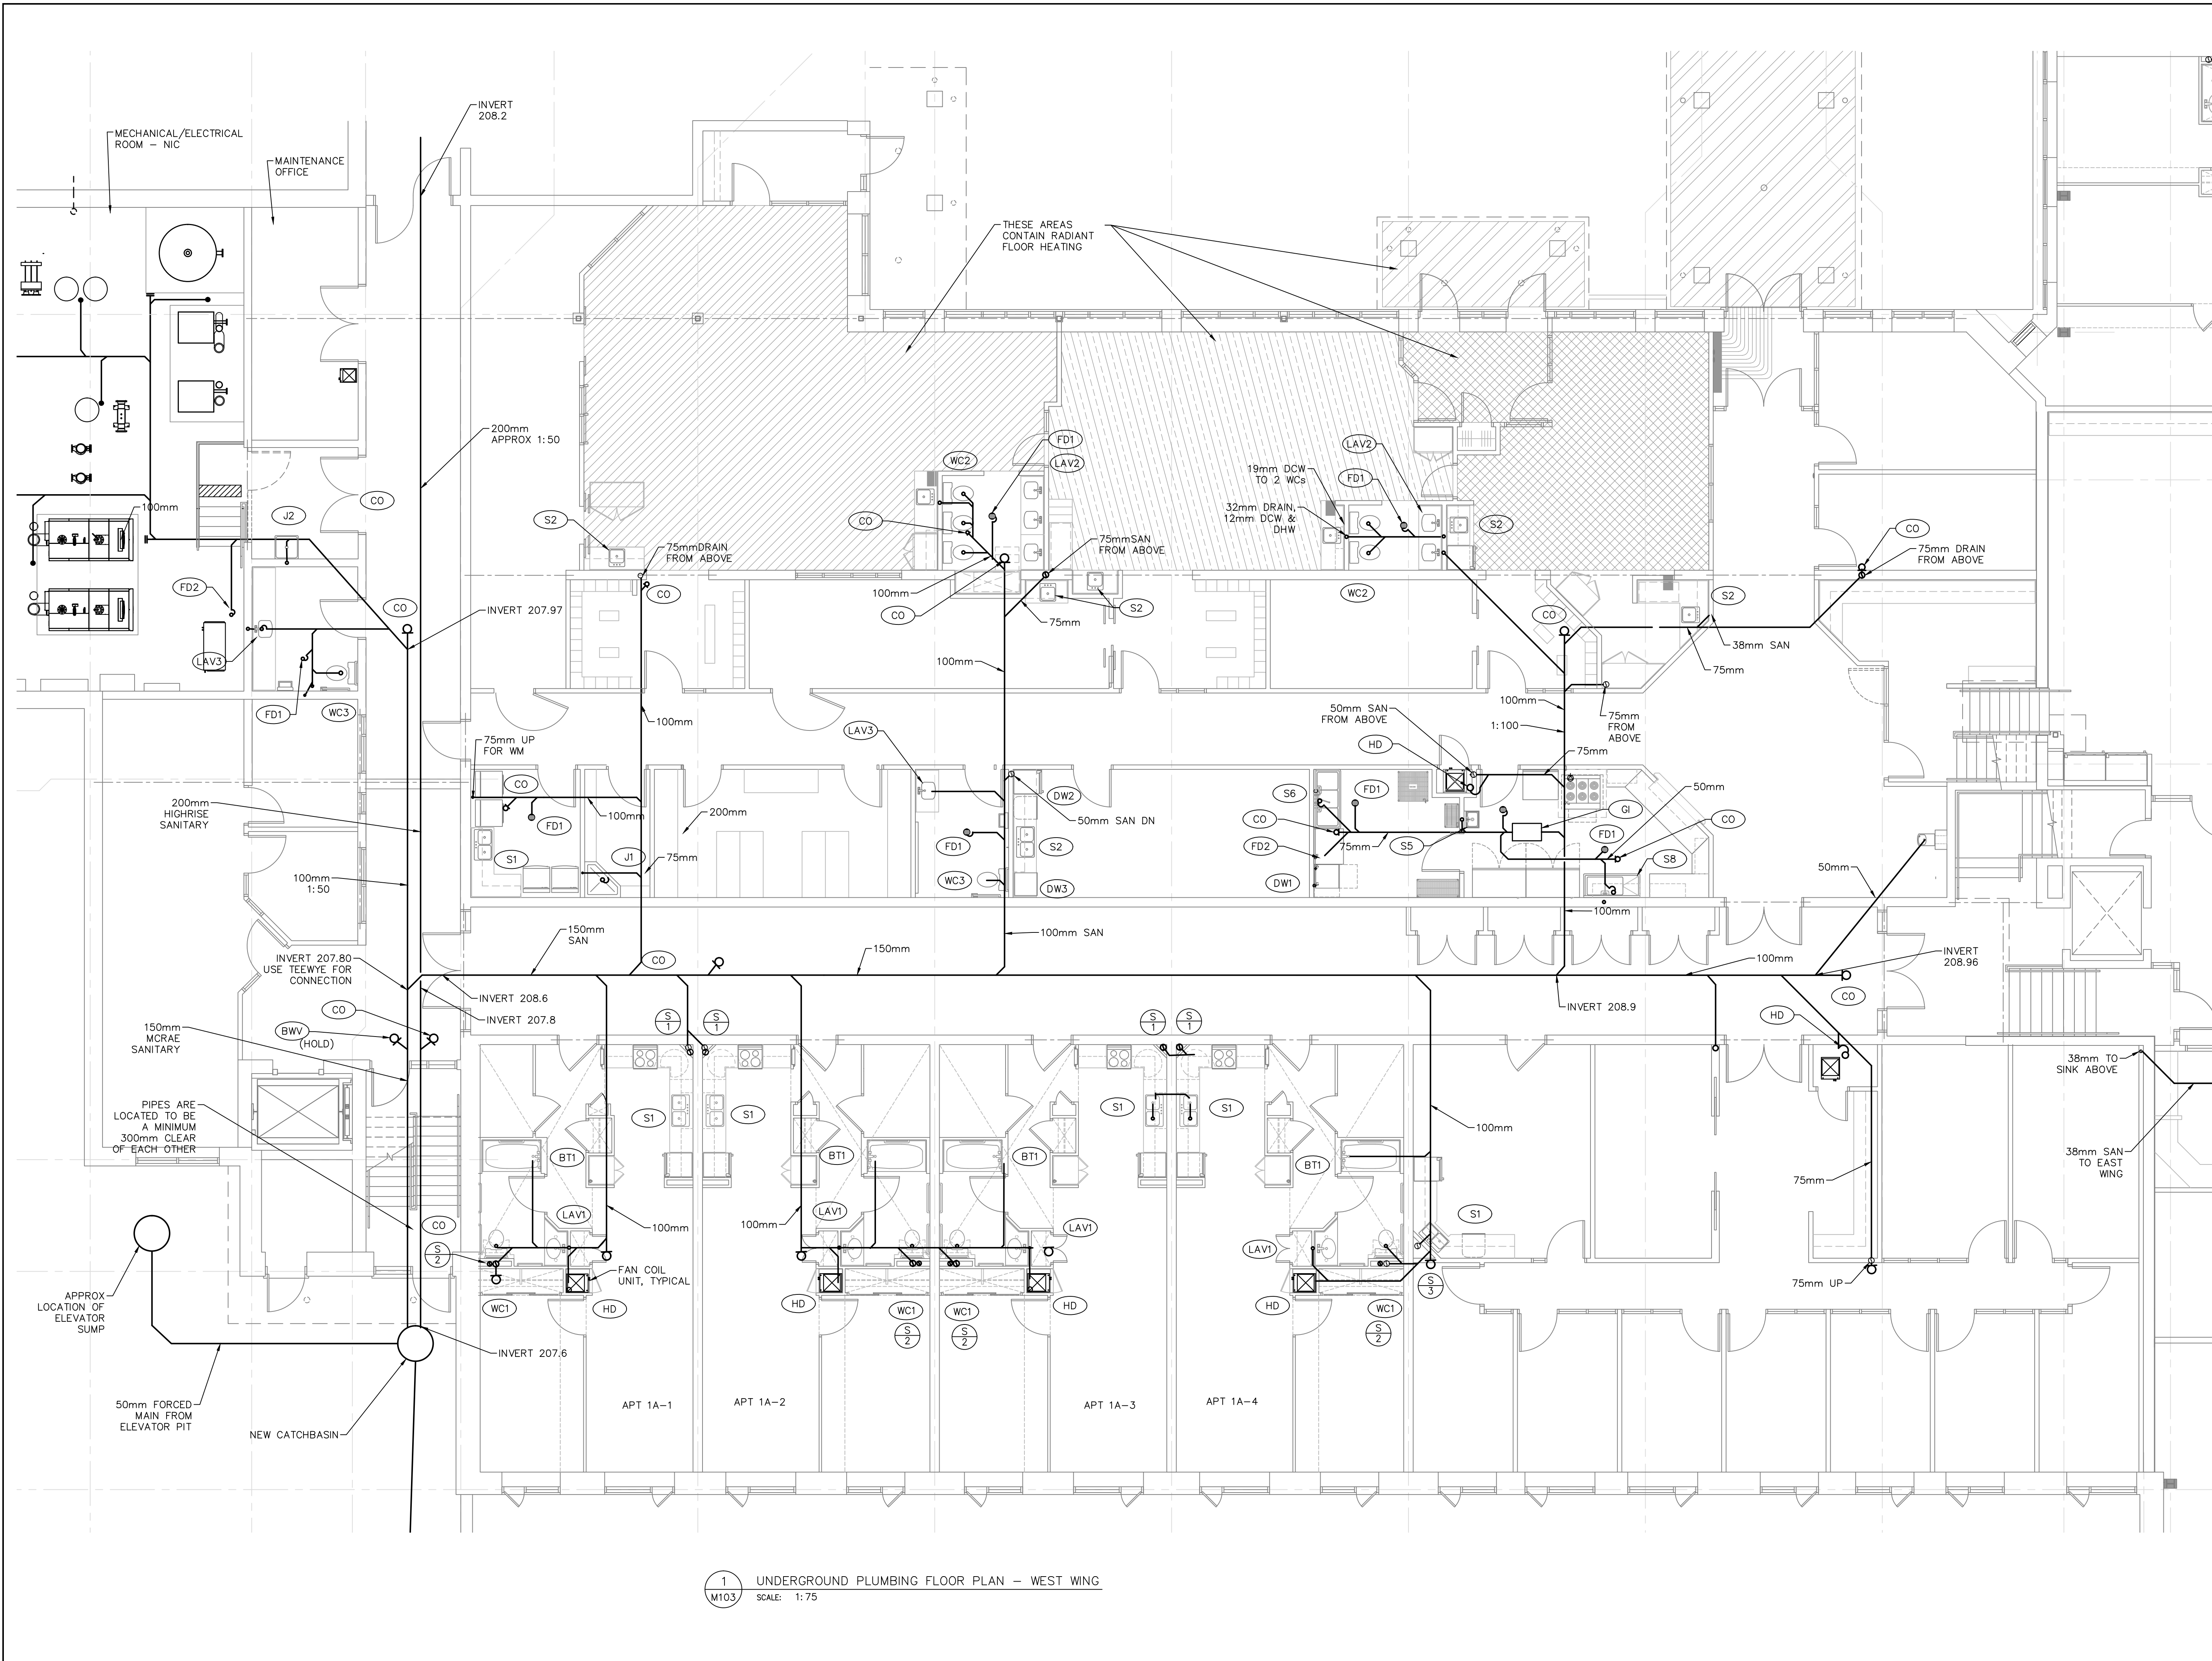

A	A Detail No
B	B Location Sheet
C	C Detailed On
A	A Detail No
B	B Sheet No where detailed

PLOT DATE: June 29 18

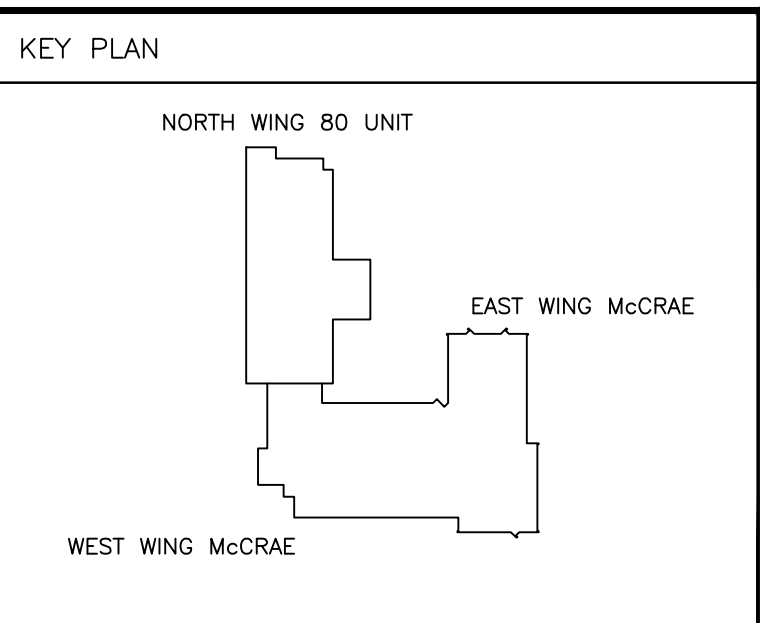

No.	Date	Revision	By
3	AUG 1 18	FOR TENDER - ADDENDUM 4	
2	JUN 27 18	FOR TENDER	
1	JUN 4 18	FOR PERMIT	
0	MAY 17 18	FOR REVIEW	

**NOVADYNE**  
 269 North Indian Road  
 Hastings, ON  
 K0L 1Y0  
 Tel: (705) 696-2119  
 Fax: (705) 696-2912

Orientation: PROJECT NORTH

Seal: REGISTERED PROFESSIONAL ENGINEER  
 A.G. BUCHKOWSKI  
 JUNE 4, 2018  
 PROVINCE OF ONTARIO  
 MECHANICAL

Project: McRAE PROPERTY DEVELOPMENT  
 553 BONACCORD STREET,  
 PETERBOROUGH, ON

Client: PETERBOROUGH HOUSING CORPORATION  
 526 McDONNELL STREET,  
 PETERBOROUGH, ONTARIO

Drawing Title: ENLARGED UNDERGROUND PLUMBING PLAN - WEST WING

Drawn By A. BUCHKOWSKI	Date JULY 2017
Checked By A. BUCHKOWSKI	Scale AS NOTED
Project No 0495	Sheet No M103
	Rev. No 4

1 UNDERGROUND PLUMBING FLOOR PLAN - WEST WING  
 M103 SCALE: 1:75